

REV	DESCRIPTION	DATE	APPROV

DESIGNED BY	JKT
CHECKED BY	DAB
DRAWN BY	DAB
REVIEWED BY	JKT
SUBMITTED BY	JKT

DEPARTMENT OF THE AIR FORCE
 AIR COMBAT COMMAND
 LANGLEY AFB VA
 CIVIL ENGINEERING OFFICE

Renovations to
 Building 366
 FLOOR PLAN
 - NEW WORK

PROJECT NUMBER
 MUJH-04-4216
 BDC DRAWING NUMBER
 FY


A-101
 SHEET OF

WALLER
 TODD &
 SADLER
 ARCHITECTS

95%
 SUBMITTAL
 16 MAY 05

KEYNOTES THIS SHEET

1. INSTALL EXISTING BUSHES AS REQUIRED AFTER NEW BRICK VENEER HAS BEEN COMPLETED
2. EXISTING CONCRETE SIDEWALK
3. INSTALL EXISTING PLANTING BACK TO ORG CONDITION
4. LINE OF EXISTING ELEC TRANSFORMER
5. INSTALL EXISTING GAS METER AS REQUIRED TO AFTER NEW BRICK VENEER HAS BEEN INSTALLED
6. EXTEND EXISTING HOSE BIBB AS REQUIRED
7. EXTEND EXISTING ELEC OUTLET
8. INSTALL EXISTING ELEC DISCONNECT FOR MECH UNIT
9. EXISTING GROUNDING ROD AND CABLE
10. EXTEND EXISTING PLUMBING CLEANOUT AS REQUIRED
11. EXISTING MECH UNIT
12. EXTEND EXISTING WALL TEMP SENSER WIRING AS REQUIRED
13. EXTEND EXISTING PHOTO ELEC CELL WIRING
14. INSTALL EXISTING WALL LIGHT FIXTURE
15. EXTEND EXISTING WALL SPRINKLER SYSTEM CONTROL BOX WIRING
16. EXISTING WATER BOX
17. EXISTING GRASS AREA

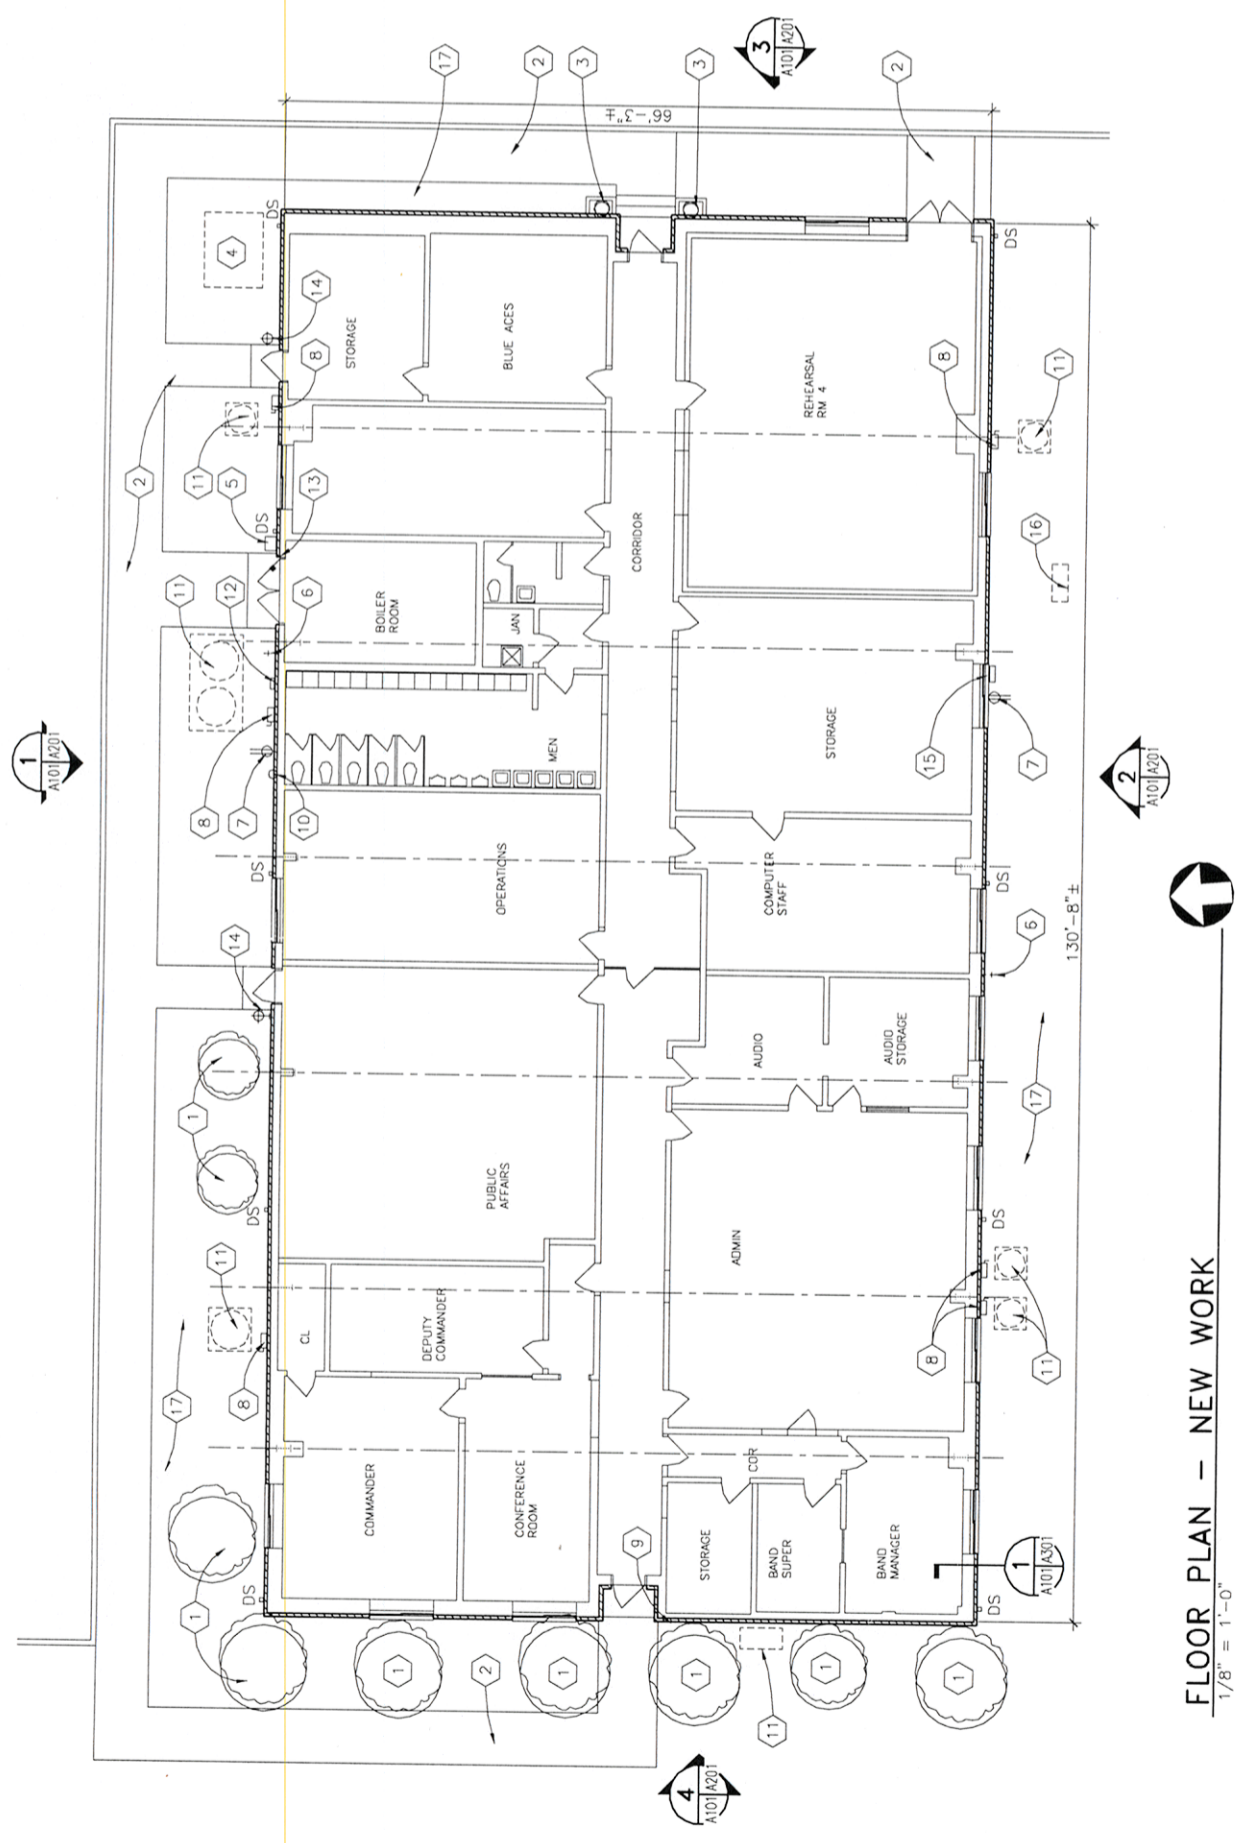

FLOOR PLAN - NEW WORK
 1/8" = 1'-0"

GRAPHIC SCALES
 1/8" = 1'-0" 0' 4' 8' 16' 24'